



SERVICE DATA					
SERVICE	DATE	INIT.	SERVICE	DATE	INIT.
SAN SEWERS			GAS MAINS		
STORM SEWERS			BELL U/G CABLE		
WATERMANS			HYDRO U/G CABLE		
TRANSIT			ONT. HYDRO		
PARKS & REC.			CTV		
ONT. CLEAN WATER					

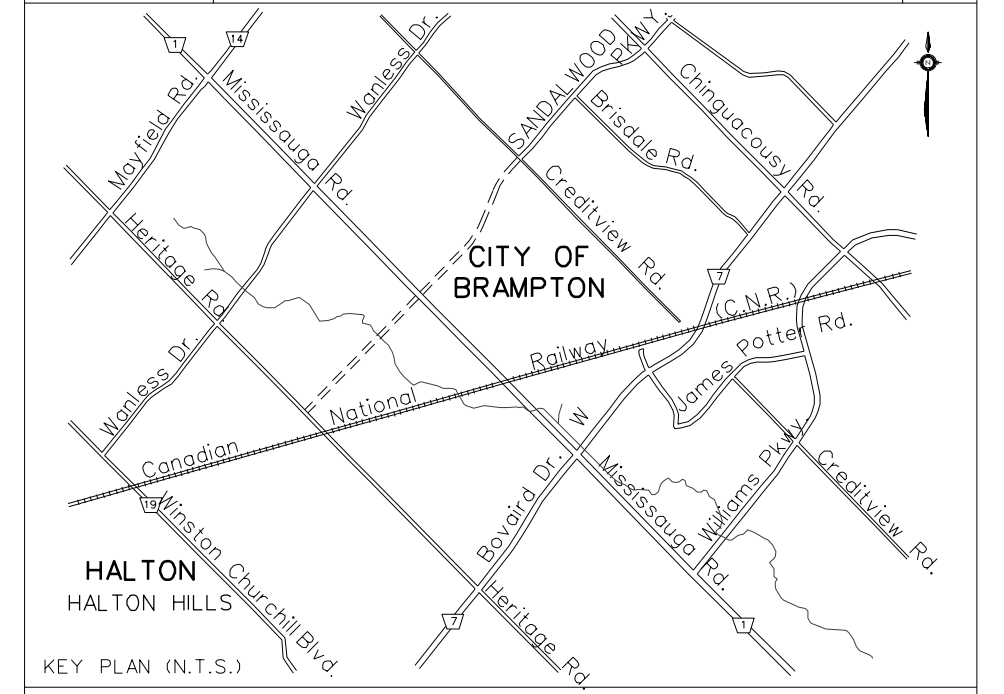

**HALTON**  
 HALTON HILLS  
 KEY PLAN (N.T.S.)

**AECOM**

AECOM CANADA Ltd.  
 300 TOWN CENTRE BLVD., MARKHAM,  
 ONTARIO, CANADA L3R 5Z6  
 T905.477.8700 F905.477.1456

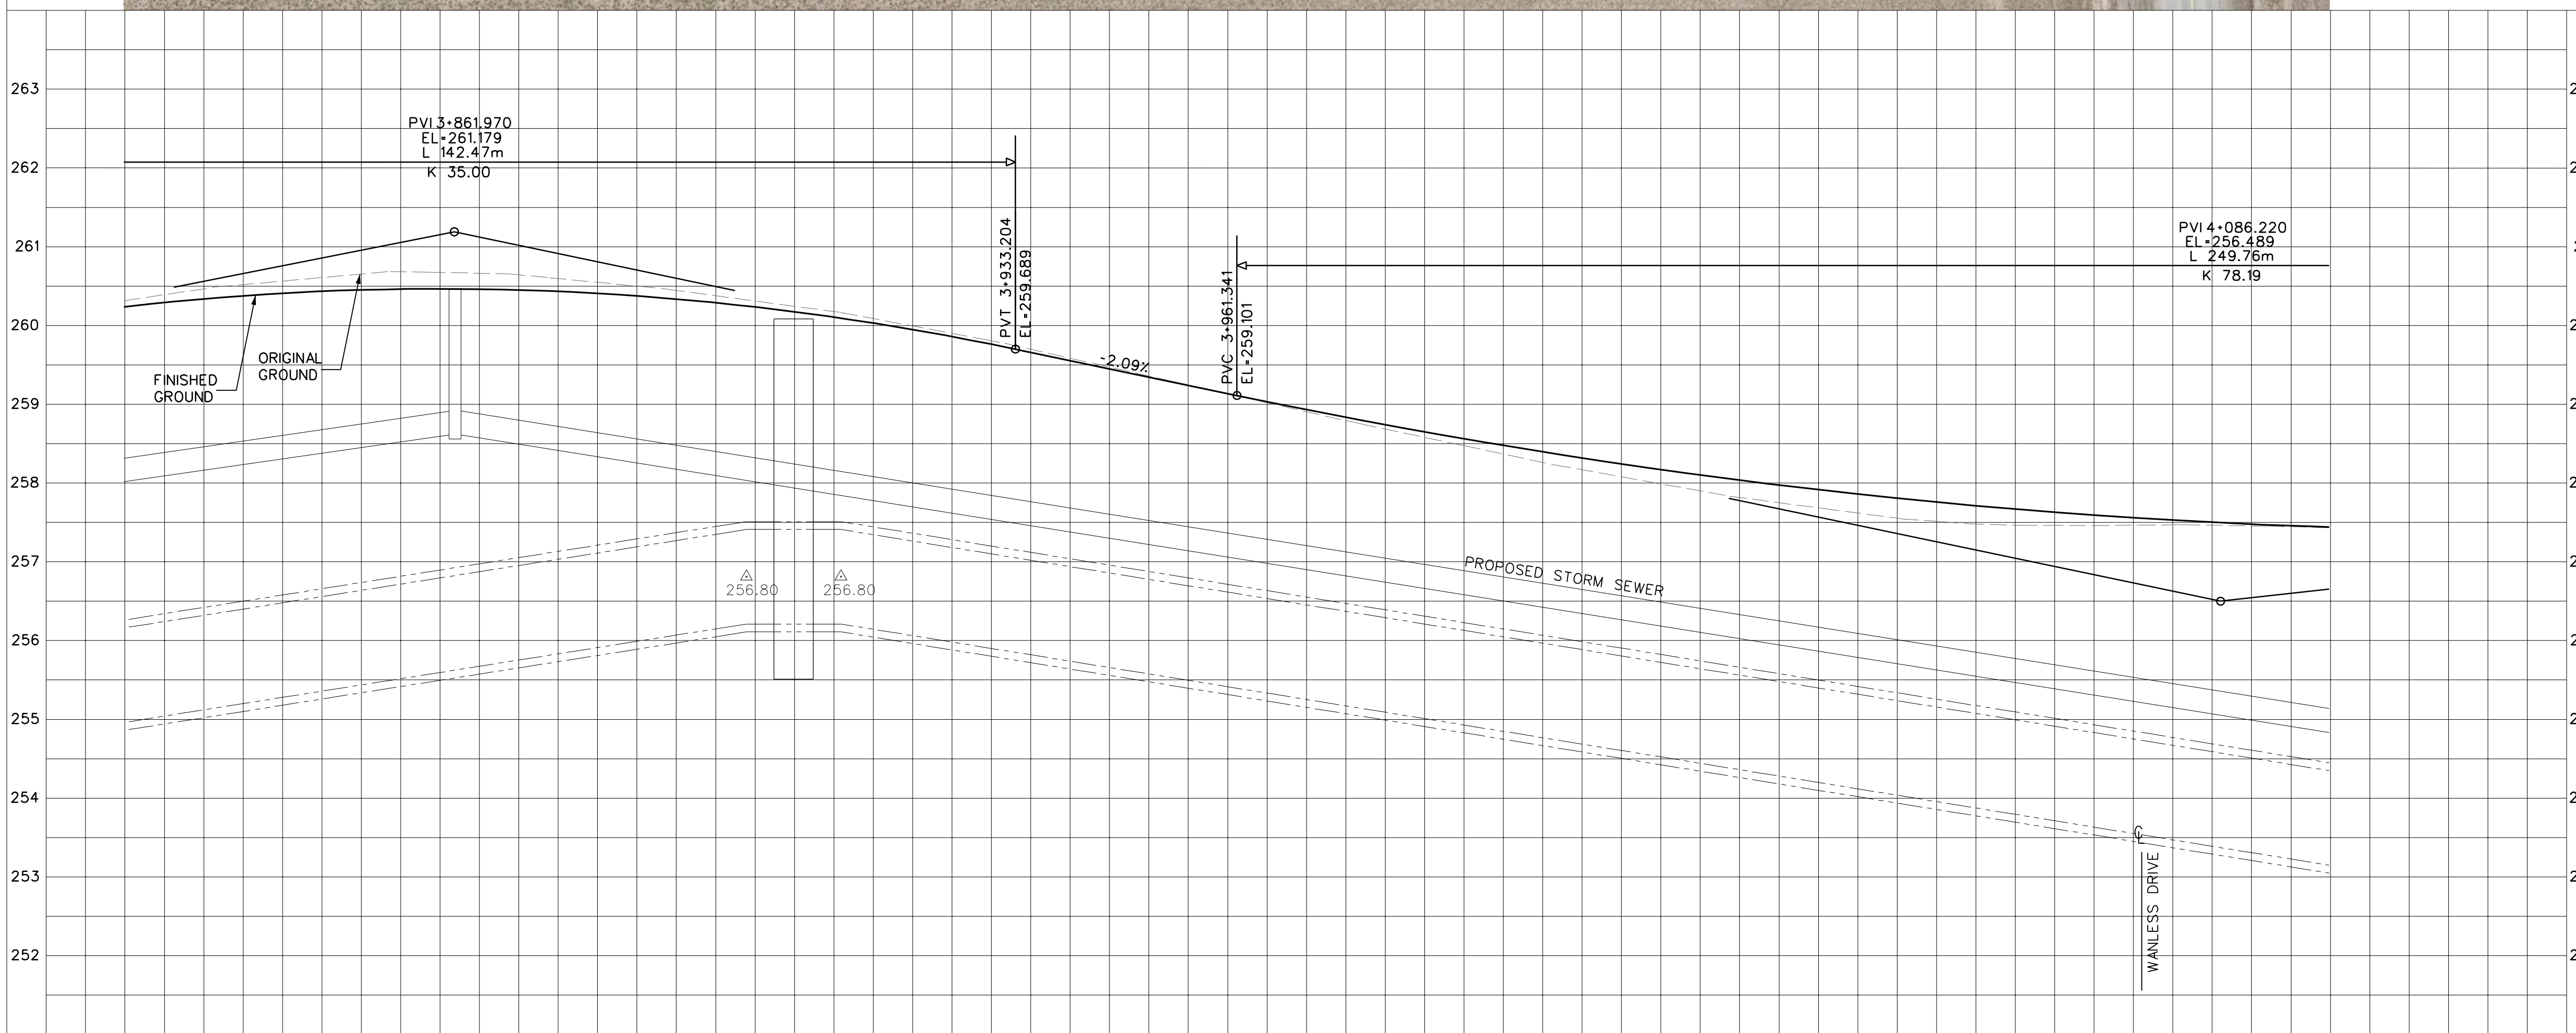

**General Notes**

- All Driveways ASPHALT Unless Otherwise Noted.
- All Service Locations Are Approximate And Must Be Located Accurately In The Field
- ⊙ Denotes Building - Not Located
- ⊙ Denotes Building Located
- Type 'B' Bedding Unless Otherwise Noted (SAN)

B.M. No. Elev.

The Contractor is Responsible For Locating And Protecting All Existing Utilities Prior To And During Construction Location of Existing Utilities Approximate Only, To Be Verified In Field By Contractor.

Designed by \_\_\_\_\_ Chkd \_\_\_\_\_ Approved by \_\_\_\_\_

**NOTICE TO CONTRACTOR**

48 HOURS PRIOR TO COMMENCING WORK NOTIFY THE FOLLOWING

THE REGIONAL MUNICIPALITY OF PEEL  
 CITY OF MISSISSAUGA WORKS DEPT.  
 CITY OF BRAMPTON WORKS DEPT.  
 TOWN OF CALEDON WORKS DEPT.  
 BELL TELEPHONE COMPANY  
 CONSUMERS GAS COMPANY  
 MINISTRY OF TRANSPORTATION  
 ONTARIO CLEAN WATER AGENCY  
 HYDRO ELECTRIC POWER COMM. OF ONTARIO  
 HYDRO ELECTRIC COMM. CITY OF MISSISSAUGA  
 HYDRO ELECTRIC COMM. CITY OF BRAMPTON  
 CABLE TELEVISION

10m 0 10 20 30m HORIZONTAL SCALE  
 1m 0 1 2 3m VERTICAL SCALE

**Region of Peel**  
 Working for you

MISSISSAUGA ROAD  
 (FROM BOVAIRD DR. TO MAYFIELD RD.)  
 PLAN AND PROFILE

Sta. 3+820.00 To Sta. 4+100.00

260.226	260.398	260.455	260.398	260.226	259.941	259.547	259.129	258.733	258.388	258.094	257.852	257.660	257.520	257.431	PR. ROAD ELEV.	Lots
260.23	260.40	260.45	260.40	260.23	259.94	259.55	259.13	258.73	258.39	258.09	257.85	257.66	257.52	257.43	EX. ROAD ELEV.	Area
3+820	3+840	3+860	3+880	3+900	3+920	3+940	3+960	3+980	4+000	4+020	4+040	4+060	4+080	4+100	ROAD CHAINAGE	Project No. 105163

Checked by	P.C.	Drawn by	V.M.	Project No.	105163
Date	NOV 2012	Sheet	11 of 19	Plan No.	PP11