





MATCH LINE - STA 4+940  
SEE DRAWING PP15

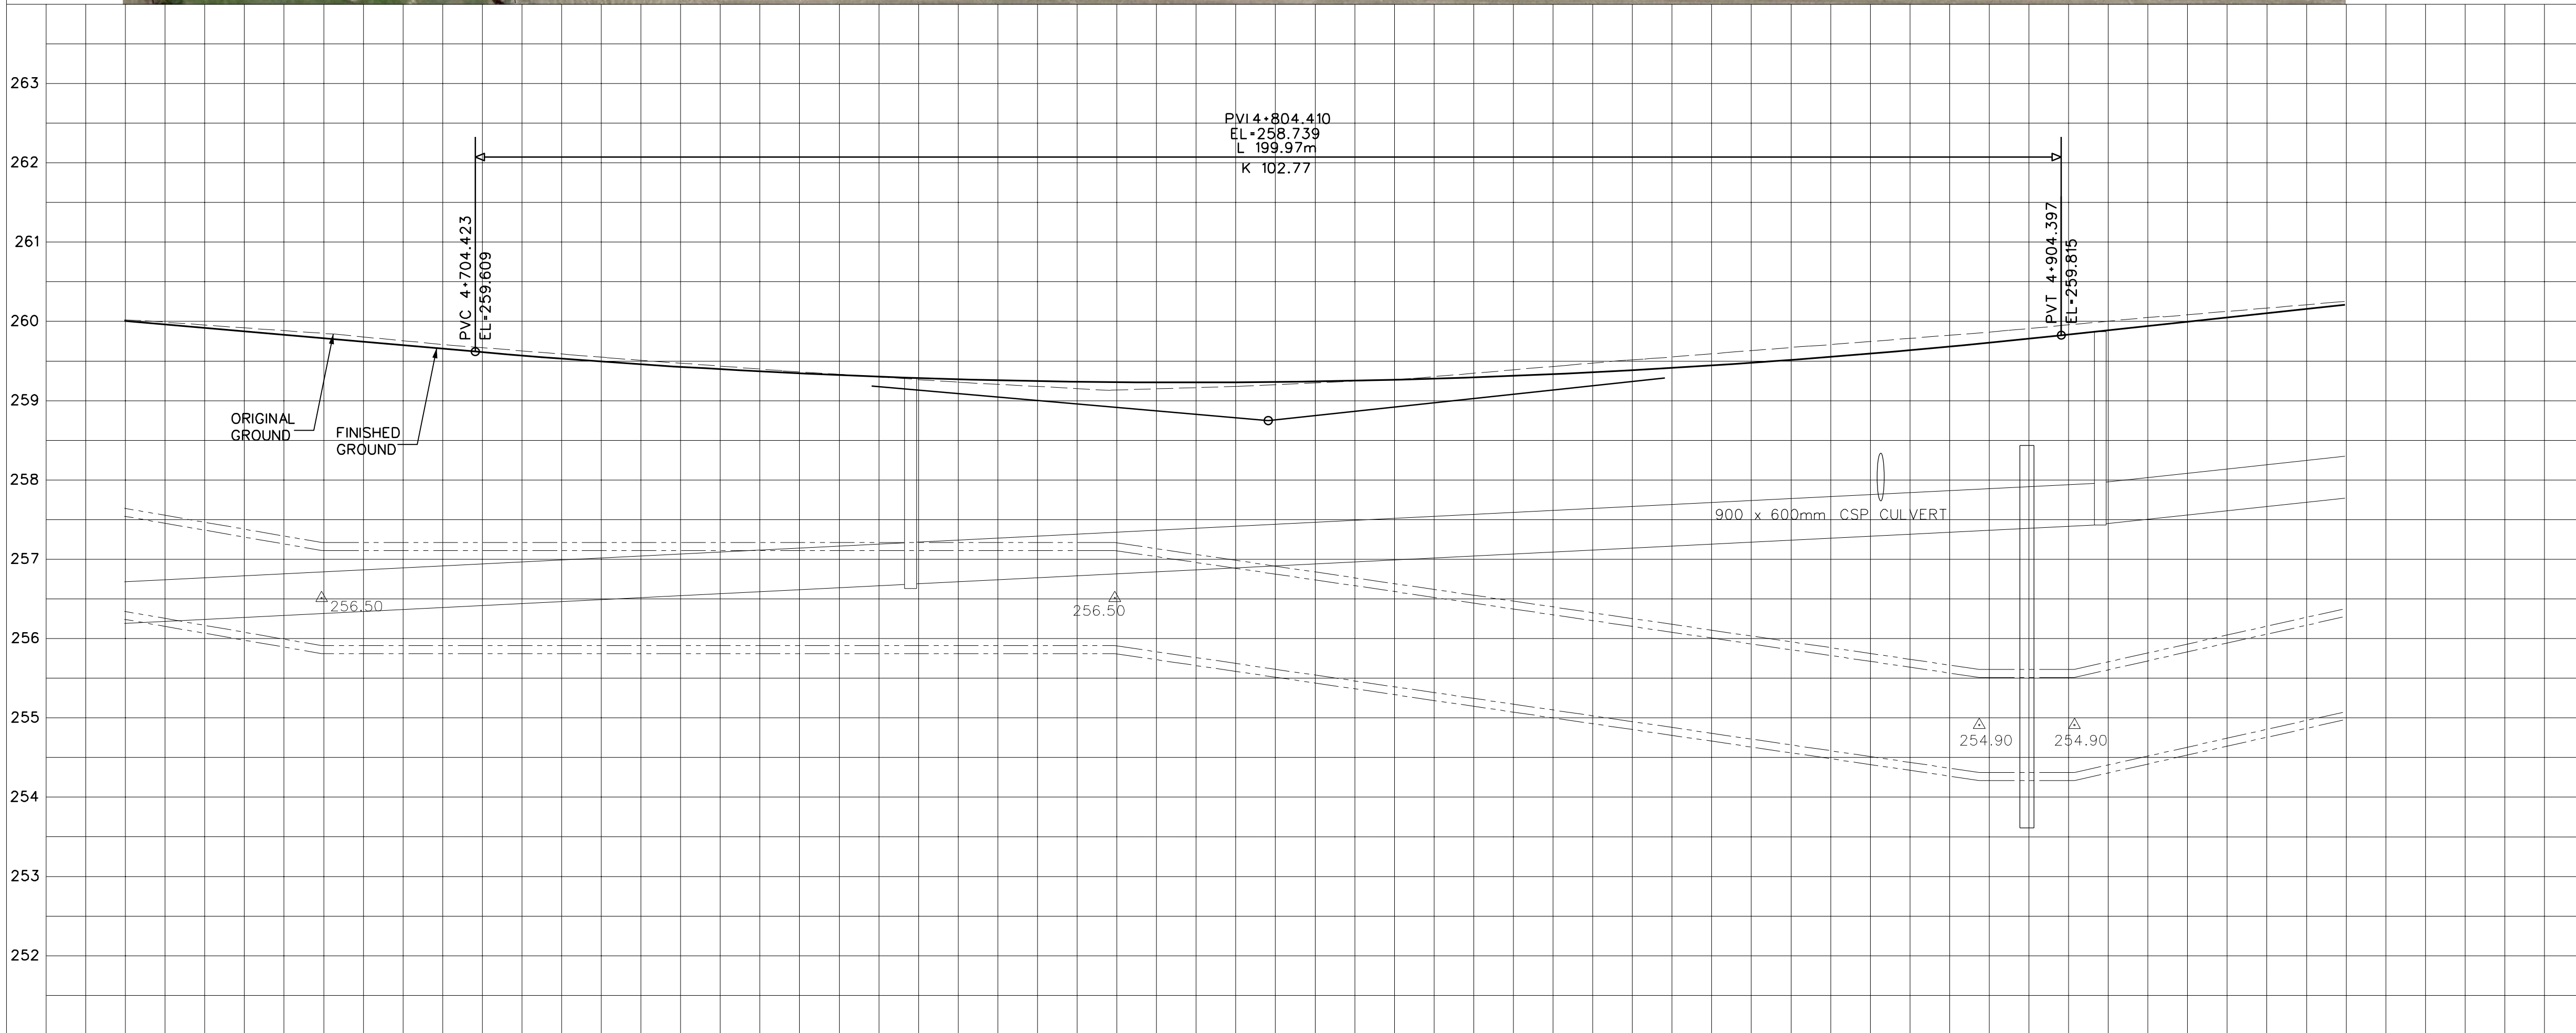

259.995	259.821	259.647	259.485	259.361	259.276	259.229	259.222	259.254	259.324	259.433	259.582	259.769	259.983	260.199	PR. ROAD ELEV.
260.00	259.82	259.65	259.49	259.36	259.28	259.23	259.22	259.25	259.32	259.43	259.58	259.77	259.98	260.20	EX. ROAD ELEV.
4+660	4+680	4+700	4+720	4+740	4+760	4+780	4+800	4+820	4+840	4+860	4+880	4+900	4+920	4+940	ROAD CHAINAGE

SERVICE DATA					
SERVICE	DATE	INIT.	SERVICE	DATE	INIT.
SAN SEWERS			GAS MAINS		
STORM SEWERS			BELL U/G CABLE		
WATER MAINS			HYDRO U/G CABLE		
TRANSIT			ONT. HYDRO		
PARKS & REC.			CTV		
ONT. CLEAN WATER					

REVISIONS		
DATE	DETAILS	INIT.

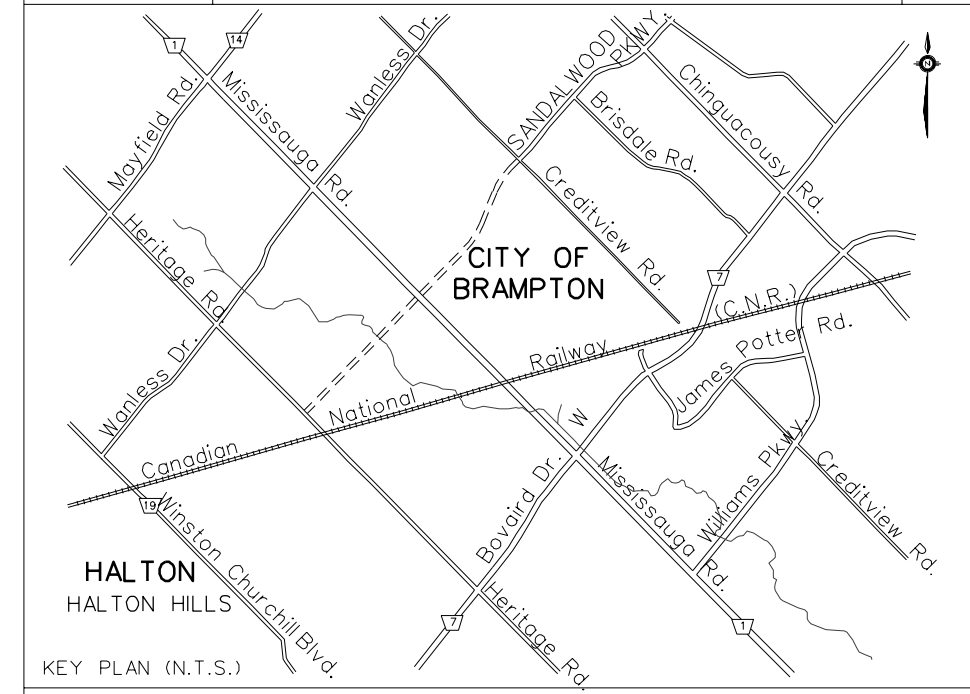

**AECOM**

AECOM CANADA Ltd.  
300 TOWN CENTRE BLVD., MARKHAM,  
ONTARIO, CANADA L3R 5Z6  
T905.477.8700 F905.477.1456


**General Notes**

- All Driveways ASPHALT Unless Otherwise Noted
- All Service Locations Are Approximate And Must Be Located Accurately In The Field
- ⊙ Denotes Building - Not Located
- ⊙ Denotes Building Located
- Type 'B' Bedding Unless Otherwise Noted (SAN)

B.M. No. Elev.  
The Contractor is Responsible For Locating And Protecting All Existing Utilities Prior To And During Construction Location of Existing Utilities Approximate Only, To Be Verified In Field By Contractor.

Designed by \_\_\_\_\_ Chkd \_\_\_\_\_ Approved by \_\_\_\_\_

**NOTICE TO CONTRACTOR**  
48 HOURS PRIOR TO COMMENCING WORK NOTIFY THE FOLLOWING:  
THE REGIONAL MUNICIPALITY OF PEEL  
CITY OF MISSISSAUGA WORKS DEPT.  
CITY OF BRAMPTON WORKS DEPT.  
TOWN OF CALEDON WORKS DEPT.  
BELL TELEPHONE COMPANY  
CONSUMERS GAS COMPANY  
MINISTRY OF TRANSPORTATION  
ONTARIO CLEAN WATER AGENCY  
HYDRO ELECTRIC POWER COMM. OF ONTARIO  
HYDRO ELECTRIC COMM. CITY OF MISSISSAUGA  
HYDRO ELECTRIC COMM. CITY OF BRAMPTON  
CABLE TELEVISION

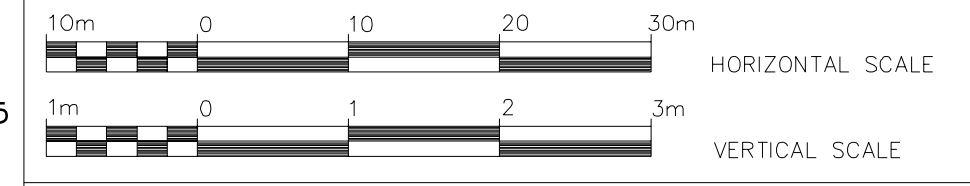

**Region of Peel**  
Working for you

**MISSISSAUGA ROAD**  
(FROM BOVAIRD DR. TO MAYFIELD RD.)  
PLAN AND PROFILE

Sta. 4+660.00	To Sta. 4+940.00	PR. ROAD ELEV.	Lots	Area	Project No.
		EX. ROAD ELEV.	Checked by P.C.	Drawn by V.M.	105163
		ROAD CHAINAGE	Date NOV 2012	Sheet 14 of 19	Plan No. PP14