



C:\Users\David.coulting\OneDrive - Cima\Desktop\Peel Region Standards\Legends\Peel Legend - P&ID - Other Symbols  
Print Date: 2025-08-01 11:14:25 AM  
ANSI C Title Block Revision A. Designed by Eric Leitner. ©2025 Peel Region. All Rights Reserved.

Transportation Vehicles

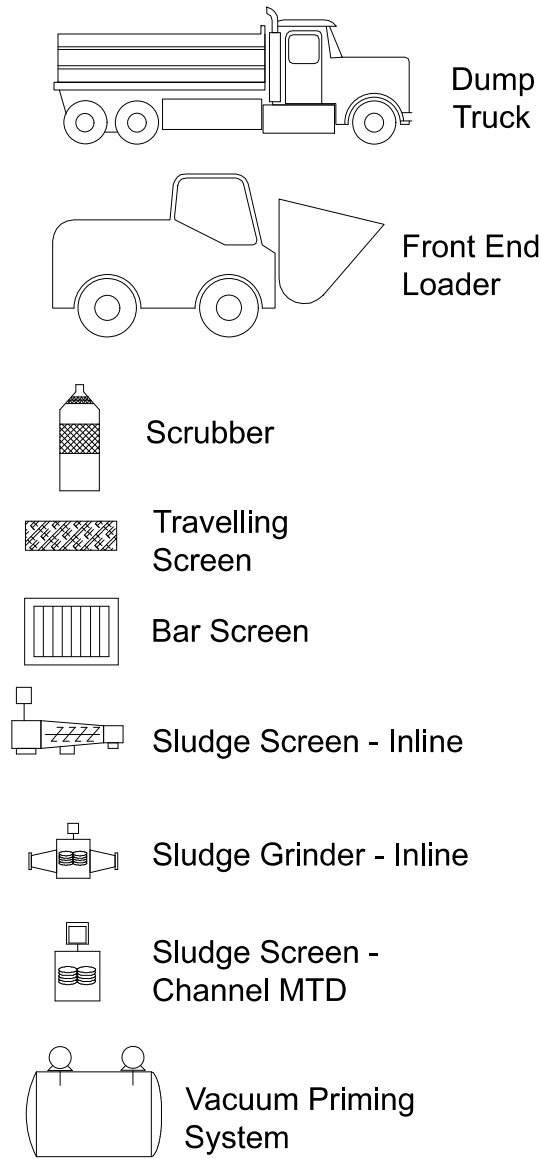


Note XX: CS = Constant Speed  
2S = Two Speed  
VS = Variable Speed


Water and Wastewater Process Equipment Symbols

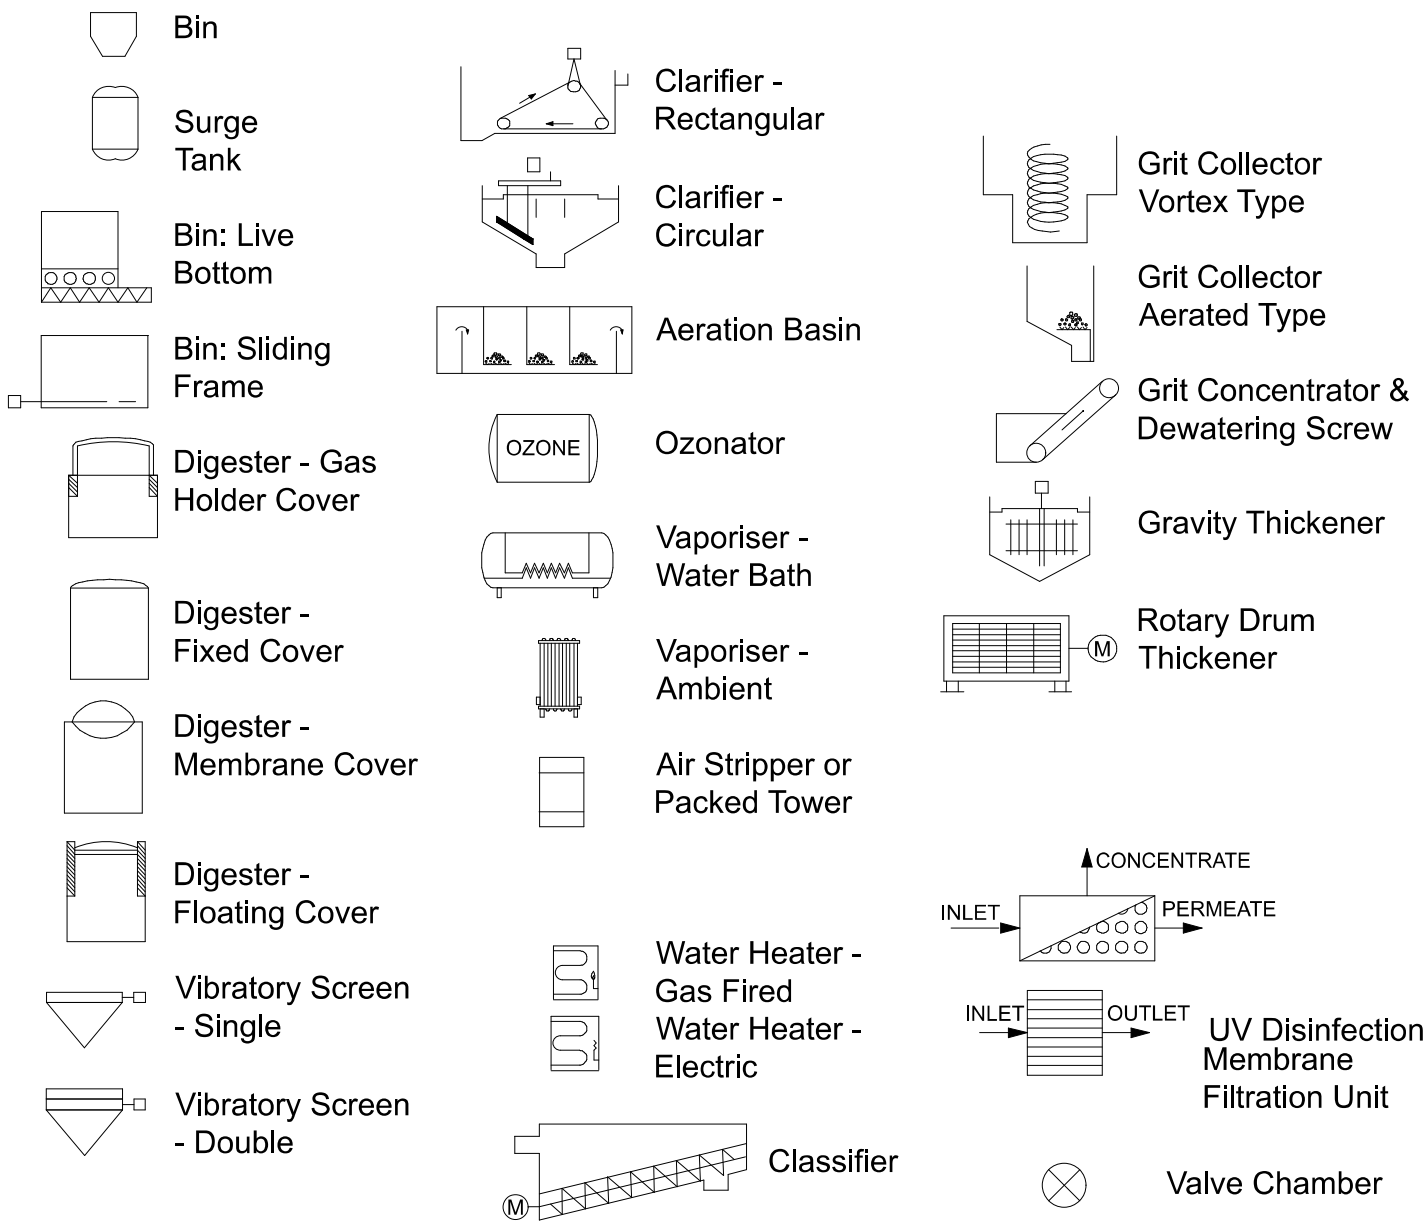


Primary Element & Fitting Symbols

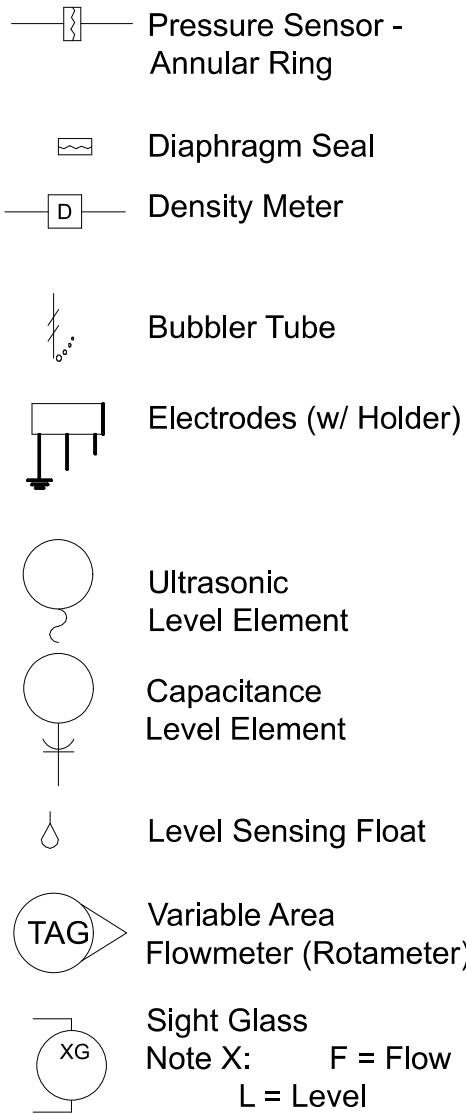


Miscellaneous Mechanical & Piping Symbols

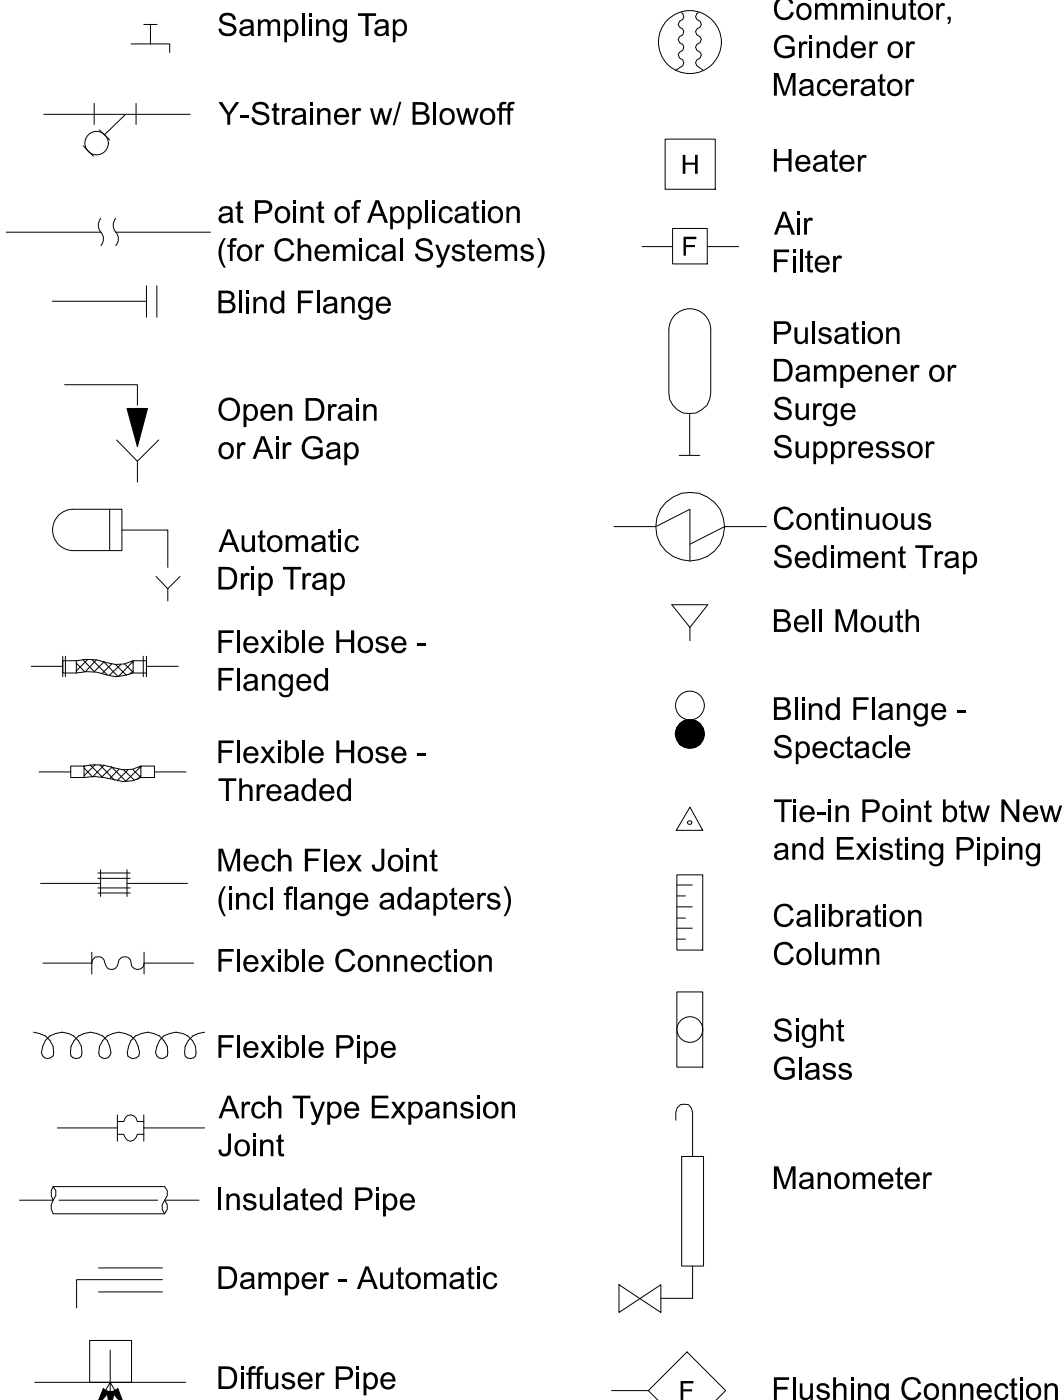


Pump and Blower Symbols

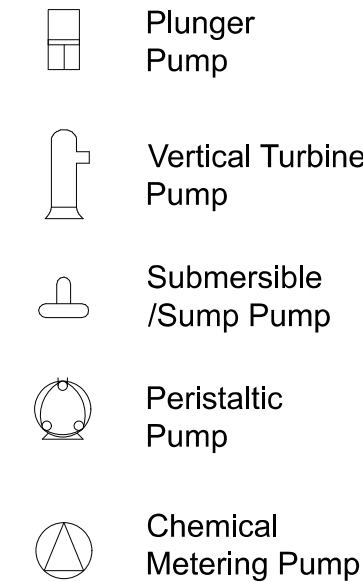

Valve and General Piping Symbols

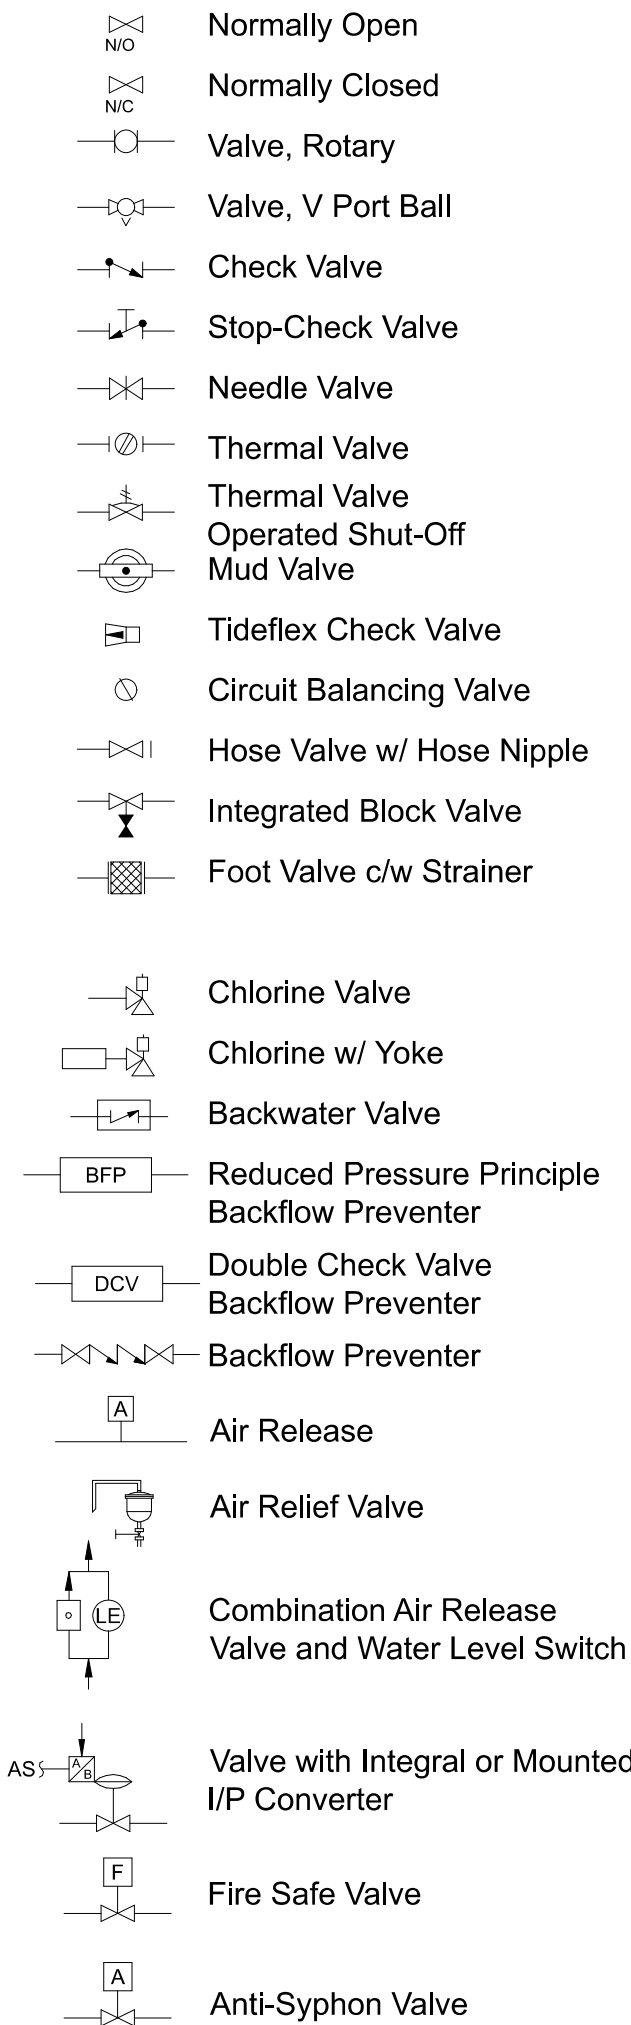

Non-ISA Gate Symbols

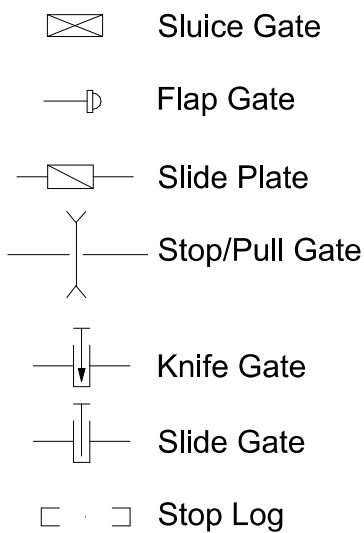

RESOURCE DRAWING

This resource drawing is based on available records and data supplied by third parties, some of which may not have been verified. It is being provided as a courtesy, without any warranty, express or implied, as to its accuracy or completeness. It may not reflect current site conditions or post-construction changes. It does not include a professional engineer's seal and is not to be considered a certified record drawing. Peel Region makes no representation or guarantee regarding the accuracy of this resource drawing and disclaims any responsibility or liability for loss, damage, or injury resulting from its use. Users are solely responsible for verifying the accuracy and completeness of this resource drawing before relying upon it for any purpose.



10 Peel Centre Drive  
Suites A and B  
Brampton, ON L6T 4B9

Client Project Description

Project Address Line  
City, Province C3C 4D4

Peel Region Project No.: 18-2108  
Peel Region Contract Number: 2022-222vPC10-1-004

Peel Region File Name: 18-2108-002-050-DI-0003

H	2025-08-31	Peel Region - Final Review Edition
G	2025-07-31	Pre-Final Review Edition
F	2025-06-27	Additional Adjustments to Elements
E	2025-04-24	End of April Edition
D	2025-04-10	Updated Edition
C	2025-03-10	Updated Edition
Mark	Date	Description

Revision History

Filename: 18-2108-002-050-DI-0003  
Version: 2025

Consultant Project Number: 20024323	Consultant Project Manager: Eric Leitner, PMP
Drawn: Eric Leitner, C.Tech.	Date (yyyy-mm-dd): 2025-06-27
Checked: Catherine Ledo	Date (yyyy-mm-dd): 2025-08-31
Approved: James Lavhey	Date (yyyy-mm-dd): 2025-08-31

Peel Region CADD Standard  
Process Legends

Non-Standard Symbolology

Page Size: ANSI C	Peel Region Sheet Number: 000-DI-0003	Rev: H
Scale: N/A	Sheet: 05 of: 08	